


TICKET BOOTH
SCALE: 1/8"=1'-0"

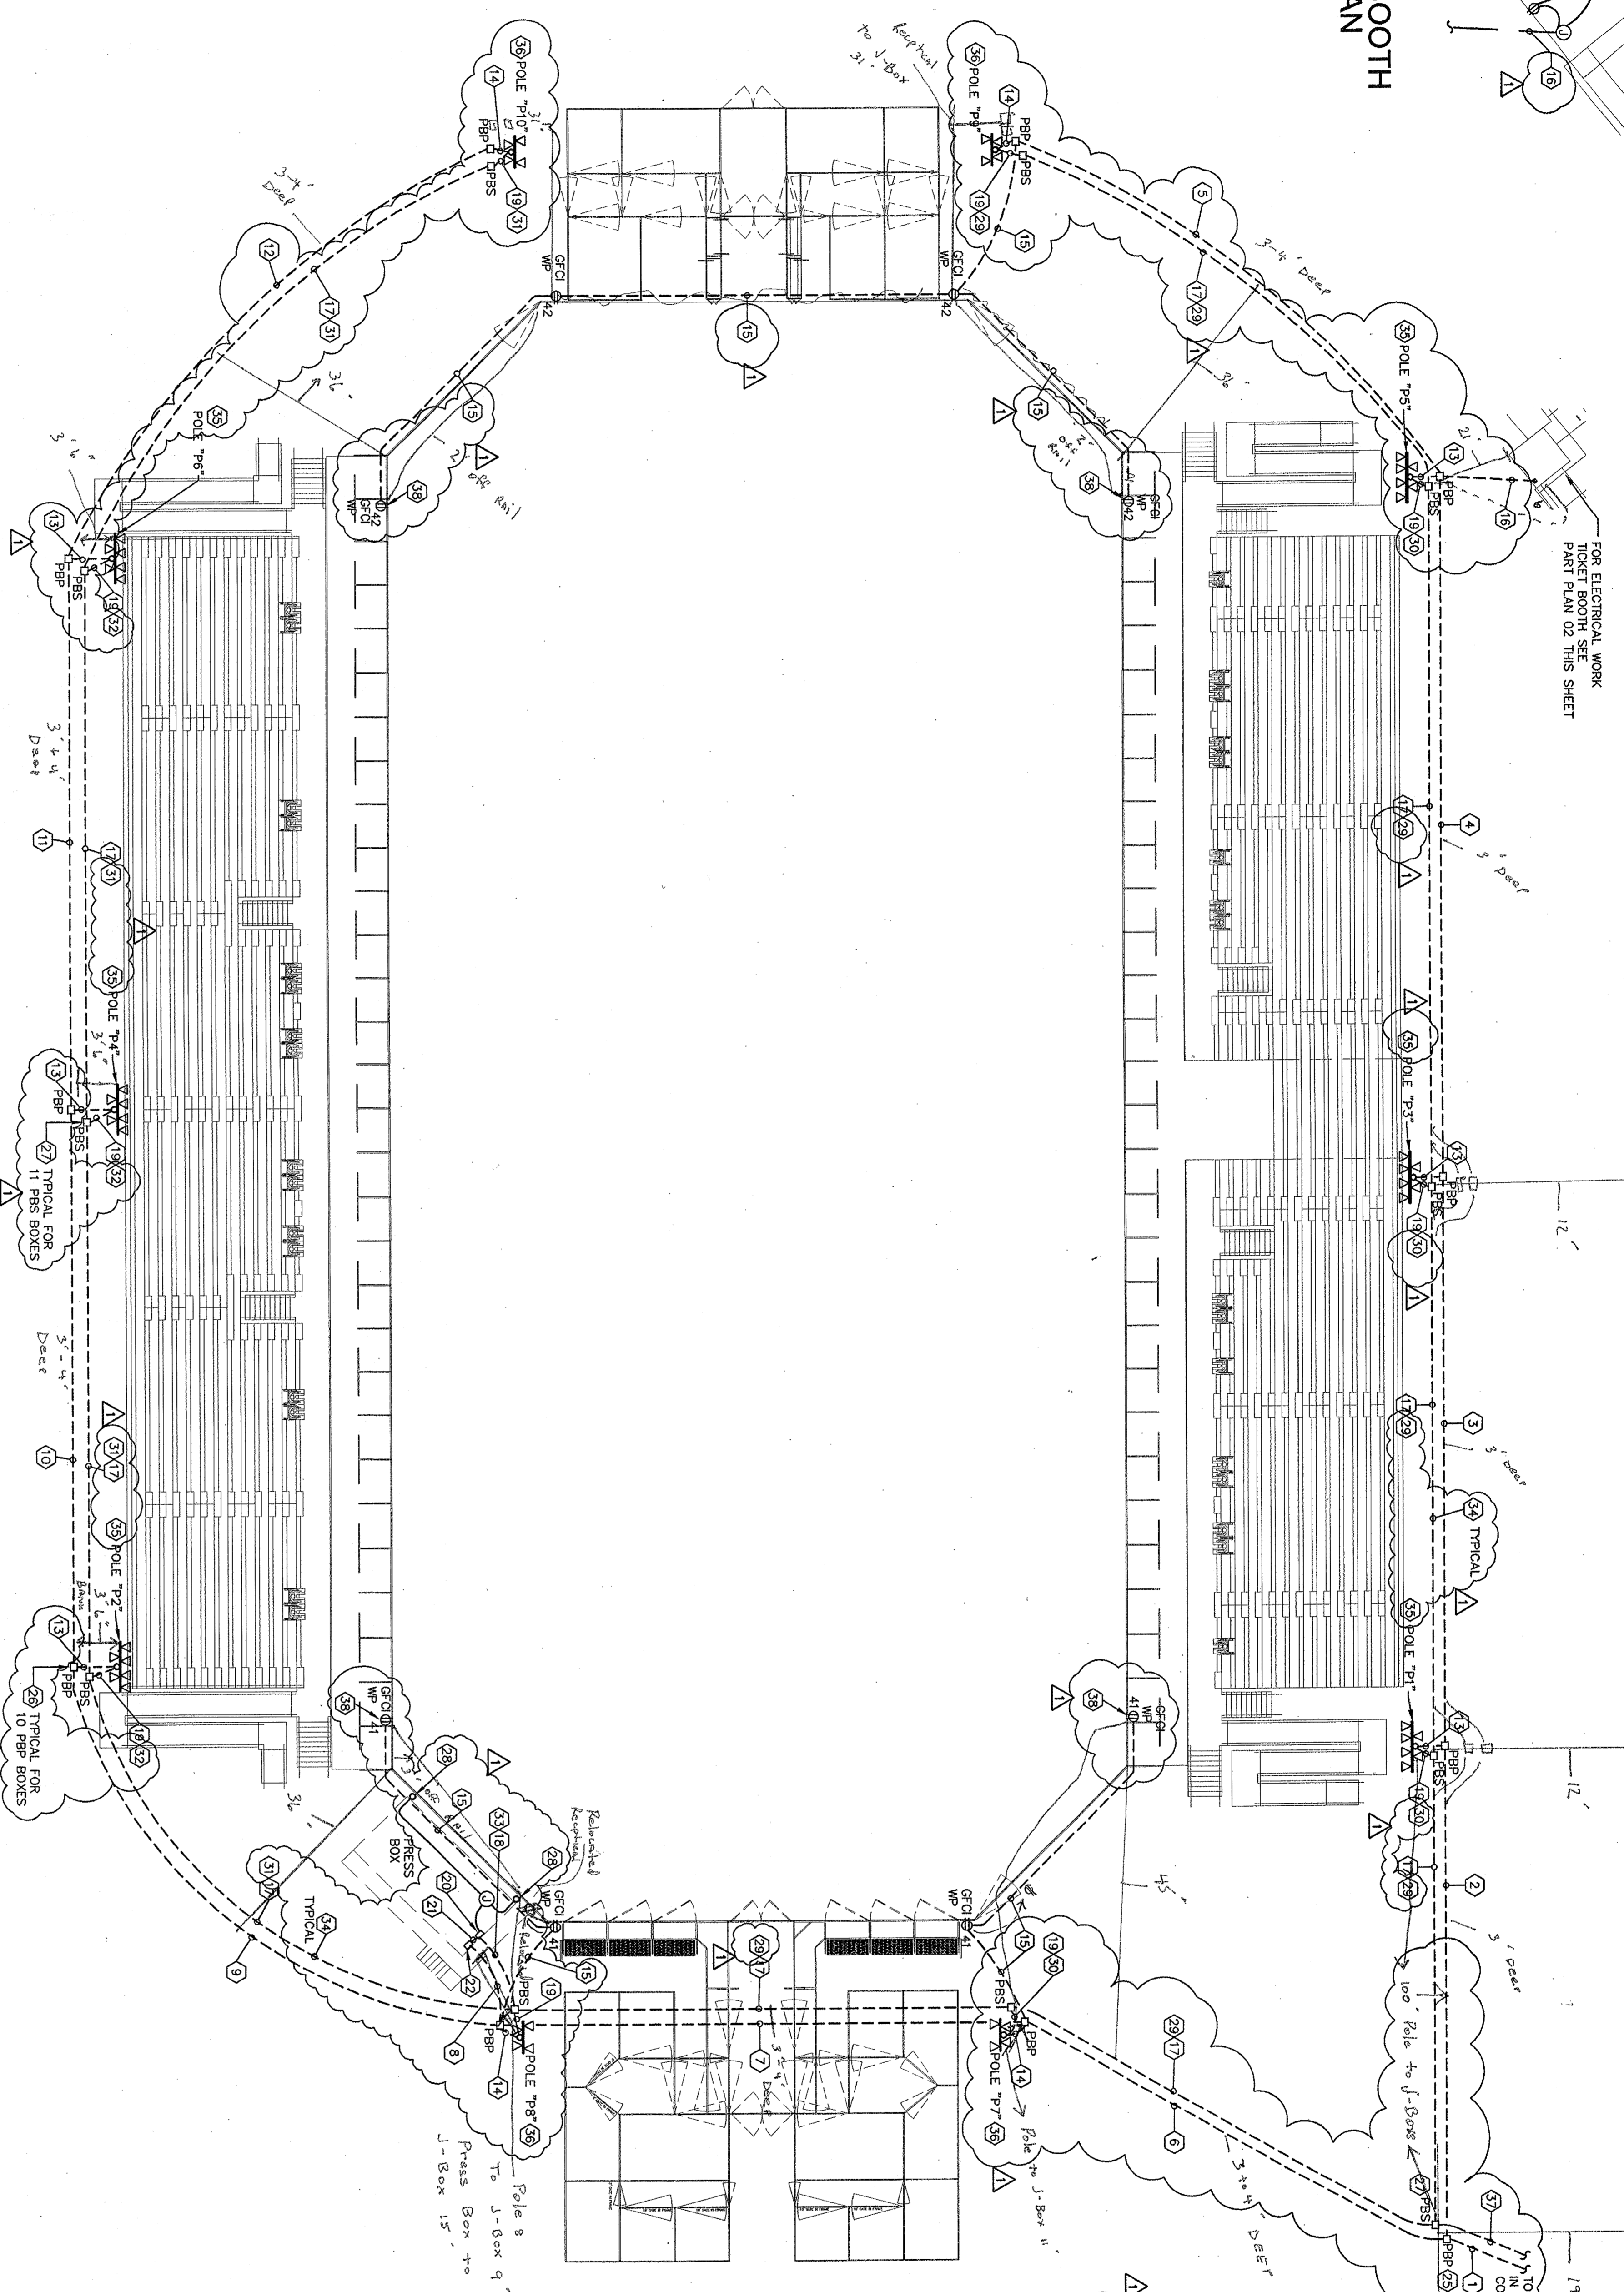

01 RODEO ARENA LIGHTING AND POWER PLAN
SCALE: 1/8"=1'-0"

RODEO ARENA LIGHTING POLE SCHEDULE

POLE ID	SPORTS LUMINAIRE	FLOODLIGHTS	POLE HEIGHT FEET	TOP OF POLE BASE FEET-AFF	EMERGENCY BATTERY PACK	SOUND SYSTEM SPEAKER
P1	AMING	AMING	50.0	5.0	ONE PROVIDED	ONE PROVIDED
P2	ARENA	BLEACHERS SEATING	50.0	5.0	ONE PROVIDED	TWO PROVIDED
P3	ARENA	BLEACHERS SEATING	50.0	5.0	ONE PROVIDED	ONE PROVIDED
P4	ARENA	BLEACHERS SEATING	50.0	5.0	ONE PROVIDED	ONE PROVIDED
P5	ARENA	BLEACHERS SEATING	50.0	5.0	ONE PROVIDED	ONE PROVIDED
P6	ARENA	BLEACHERS SEATING	50.0	5.0	ONE PROVIDED	ONE PROVIDED
P7	N/A	PERIMETER	30.0	3.0	NONE	ONE PROVIDED MOUNTED 28'-0" ABOVE GRADE
P8	N/A	PERIMETER	30.0	3.0	NONE	ONE PROVIDED MOUNTED 28'-0" ABOVE GRADE
P9	N/A	PERIMETER	30.0	3.0	NONE	ONE PROVIDED MOUNTED 28'-0" ABOVE GRADE
P10	N/A	PERIMETER	30.0	3.0	NONE	ONE PROVIDED MOUNTED 28'-0" ABOVE GRADE

KEYED NOTES CONTS

- 29 ANTENNA FOR WIRELESS MICROPHONE, MOUNTED ON BUILDING EXTERIOR CABLE IN 3/4" C AND TERMINATE IN A CAST BOX.
- 30 ONE CHANNEL 1 SOUND SYSTEM CABLE.
- 31 TWO CHANNEL 1 SOUND SYSTEM CABLE.
- 32 ONE CHANNEL 2 SOUND SYSTEM CABLE.
- 33 TWO CHANNEL 2 SOUND SYSTEM CABLE.
- 34 SOUND SYSTEM CABLE SHALL BE #12 AWG SHIELDED TWISTED PAIR, RAINWATER #2716, OR APPROVED EQUAL. SEE DETAIL 09/EB3 FOR POLE MOUNTING OF SPEAKERS.
- 35 SEE LIGHT POLE DETAIL 07/EB5.
- 36 SEE POLE FOUNDATION DETAIL 07/EB2.
- 37 MOUNT RECEIPTOR ON PERAIL ABOVE SHELF, APPROXIMATELY LOCATION AND INSTALLATION.

GENERAL NOTES

- 1. THERE SHALL BE NO POWER CONDUCTORS SPACING IN GROUND PULL BOXES. GROUND CONDUCTORS ARE EXCLUDED.

KEYED NOTES

- 1 -1/2" C, 3/4" O.D. #5000-001 TRH-1 (13,15) 2#8#6500-001 TRH-17
- 1 -1/2" C, 3/4" O.D. #5000-001 TRH-2 (13,15) 2#8#6500-001 TRH-17
- 1 -1/2" C, 3/4" O.D. #5000-001 TRH-3 (13,15) 2#8#6500-001 TRH-17
- 1 -1/2" C, 3/4" O.D. #5000-001 TRH-4 (13,15) 2#8#6500-001 TRH-17
- 1 -1/2" C, 3/4" O.D. #5000-001 TRH-5 (13,15) 2#8#6500-001 TRH-17
- 1 -1/2" C, 3/4" O.D. #5000-001 TRH-6 (13,15) 2#8#6500-001 TRH-17
- 1 -1/2" C, 3/4" O.D. #5000-001 TRH-7 (13,15) 2#8#6500-001 TRH-17
- 1 -1/2" C, 3/4" O.D. #5000-001 TRH-8 (13,15) 2#8#6500-001 TRH-17
- 1 -1/2" C, 3/4" O.D. #5000-001 TRH-9 (13,15) 2#8#6500-001 TRH-17
- 1 -1/2" C, 3/4" O.D. #5000-001 TRH-10 (13,15) 2#8#6500-001 TRH-17
- 1 -1/2" C, 3/4" O.D. #5000-001 TRH-11 (13,15) 2#8#6500-001 TRH-17
- 1 -1/2" C, 3/4" O.D. #5000-001 TRH-12 (13,15) 2#8#6500-001 TRH-17
- 1 -1/2" C, 3/4" O.D. #5000-001 TRH-13 (13,15) 2#8#6500-001 TRH-17
- 1 -1/2" C, 3/4" O.D. #5000-001 TRH-14 (13,15) 2#8#6500-001 TRH-17
- 1 -1/2" C, 3/4" O.D. #5000-001 TRH-15 (13,15) 2#8#6500-001 TRH-17
- 1 -1/2" C, 3/4" O.D. #5000-001 TRH-16 (13,15) 2#8#6500-001 TRH-17
- 1 -1/2" C, 3/4" O.D. #5000-001 TRH-17 (13,15) 2#8#6500-001 TRH-17
- 1 -1/2" C, 3/4" O.D. #5000-001 TRH-18 (13,15) 2#8#6500-001 TRH-17
- 1 -1/2" C, 3/4" O.D. #5000-001 TRH-19 (13,15) 2#8#6500-001 TRH-17
- 1 -1/2" C, 3/4" O.D. #5000-001 TRH-20 (13,15) 2#8#6500-001 TRH-17
- 1 -1/2" C, 3/4" O.D. #5000-001 TRH-21 (13,15) 2#8#6500-001 TRH-17
- 1 -1/2" C, 3/4" O.D. #5000-001 TRH-22 (13,15) 2#8#6500-001 TRH-17
- 1 -1/2" C, 3/4" O.D. #5000-001 TRH-23 (13,15) 2#8#6500-001 TRH-17
- 1 -1/2" C, 3/4" O.D. #5000-001 TRH-24 (13,15) 2#8#6500-001 TRH-17
- 1 -1/2" C, 3/4" O.D. #5000-001 TRH-25 (13,15) 2#8#6500-001 TRH-17
- 1 -1/2" C, 3/4" O.D. #5000-001 TRH-26 (13,15) 2#8#6500-001 TRH-17
- 1 -1/2" C, 3/4" O.D. #5000-001 TRH-27 (13,15) 2#8#6500-001 TRH-17
- 1 -1/2" C, 3/4" O.D. #5000-001 TRH-28 (13,15) 2#8#6500-001 TRH-17
- 1 -1/2" C, 3/4" O.D. #5000-001 TRH-29 (13,15) 2#8#6500-001 TRH-17
- 1 -1/2" C, 3/4" O.D. #5000-001 TRH-30 (13,15) 2#8#6500-001 TRH-17
- 1 -1/2" C, 3/4" O.D. #5000-001 TRH-31 (13,15) 2#8#6500-001 TRH-17
- 1 -1/2" C, 3/4" O.D. #5000-001 TRH-32 (13,15) 2#8#6500-001 TRH-17
- 1 -1/2" C, 3/4" O.D. #5000-001 TRH-33 (13,15) 2#8#6500-001 TRH-17
- 1 -1/2" C, 3/4" O.D. #5000-001 TRH-34 (13,15) 2#8#6500-001 TRH-17
- 1 -1/2" C, 3/4" O.D. #5000-001 TRH-35 (13,15) 2#8#6500-001 TRH-17
- 1 -1/2" C, 3/4" O.D. #5000-001 TRH-36 (13,15) 2#8#6500-001 TRH-17
- 1 -1/2" C, 3/4" O.D. #5000-001 TRH-37 (13,15) 2#8#6500-001 TRH-17
- 1 -1/2" C, 3/4" O.D. #5000-001 TRH-38 (13,15) 2#8#6500-001 TRH-17
- 1 -1/2" C, 3/4" O.D. #5000-001 TRH-39 (13,15) 2#8#6500-001 TRH-17
- 1 -1/2" C, 3/4" O.D. #5000-001 TRH-40 (13,15) 2#8#6500-001 TRH-17
- 1 -1/2" C, 3/4" O.D. #5000-001 TRH-41 (13,15) 2#8#6500-001 TRH-17
- 1 -1/2" C, 3/4" O.D. #5000-001 TRH-42 (13,15) 2#8#6500-001 TRH-17
- 1 -1/2" C, 3/4" O.D. #5000-001 TRH-43 (13,15) 2#8#6500-001 TRH-17
- 1 -1/2" C, 3/4" O.D. #5000-001 TRH-44 (13,15) 2#8#6500-001 TRH-17
- 1 -1/2" C, 3/4" O.D. #5000-001 TRH-45 (13,15) 2#8#6500-001 TRH-17
- 1 -1/2" C, 3/4" O.D. #5000-001 TRH-46 (13,15) 2#8#6500-001 TRH-17
- 1 -1/2" C, 3/4" O.D. #5000-001 TRH-47 (13,15) 2#8#6500-001 TRH-17
- 1 -1/2" C, 3/4" O.D. #5000-001 TRH-48 (13,15) 2#8#6500-001 TRH-17
- 1 -1/2" C, 3/4" O.D. #5000-001 TRH-49 (13,15) 2#8#6500-001 TRH-17
- 1 -1/2" C, 3/4" O.D. #5000-001 TRH-50 (13,15) 2#8#6500-001 TRH-17

RECORD DRAWING

- 1. PROJECT NO. 200025-01
- 2. DATE APRIL 4, 2003
- 3. DRAWN JCC
- 4. CHECKED JAM
- 5. REVISIONS
- 6. POSTED APPENDIX 1-7
- 7. 100% CONSTRUCTION SET

E5.1
RODEO ARENA LIGHTING AND POWER PLAN

CONSULTANTS

CH2M
Kozz Associates, Inc.
1100 West 17th Street, Suite 200
Denver, CO 80202
Tel: 303.733.2500

Structural
Curt Jumper Gardner & Assoc.
1100 West 17th Street, Suite 200
Denver, CO 80202
Tel: 303.733.2500

MECHANICAL
Smith Smith & Assoc.
1100 West 17th Street, Suite 200
Denver, CO 80202
Tel: 303.733.2500

FOODSERVICE
Frank Chemins Associates, Inc.
1100 West 17th Street, Suite 200
Denver, CO 80202
Tel: 303.733.2500

LANDSCAPING
Mary L. Goddaly Associates
1100 West 17th Street, Suite 200
Denver, CO 80202
Tel: 303.733.2500

ACOUSTICAL
Hovner and Kahn, Inc.
1100 West 17th Street, Suite 200
Denver, CO 80202
Tel: 303.733.2500

KEY PLAN

PLAN NORTH

MULTI-PURPOSE ARENA
KATY INDEPENDENT SCHOOL DISTRICT

PBR ARCHITECTS, INC.

11 Greenway Plaza
Suite 2200
Houston, TX 77046-1104
Tel: 713.865.0699